


SWITCHBOARD "M"
120/208V 3Ø 4W WYE
800 AMP BUS

SWITCHBOARD "M" SCHEDULE

1	30A	3P	RMAHU #1
2	30A	3P	RMAC #1
3	30A	3P	RMAC #2
4	30A	3P	RMAC #2
5	60A	3P	LEVELATOR
6	60A	3P	RMAHU #2
7	100A	3P	ACCU #1
8	100A	3P	ACCU #2
9	100A	3P	
10	100A	3P	
11	200A	3P	
12	225A	3P	PANEL A
13	225A	3P	PANEL B
14	225A	3P	PANEL P1
15	225A	3P	PANEL P2
16	225A	3P	EXIST. PANEL
17	BUSSED	SPACE	

LOWER FLOOR/TUNNEL PLAN
SCALE 1/8" = 1'-0"

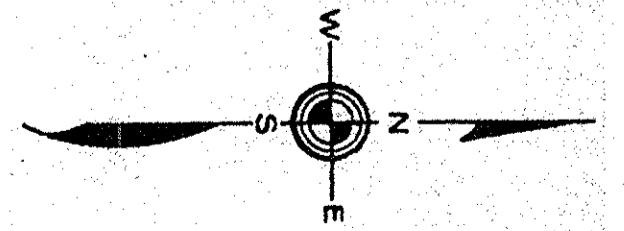

ROBY, QUINTAL & EVERSON
CONSULTING ENGINEERS
MITCHELL, SOUTH DAKOTA



REVISED DATE 7/29/94	CLASSROOM/MULTI-PURPOSE ADD. ZION LUTHERAN CHURCH ABERDEEN, SOUTH DAKOTA	BASEMENT FLOOR PLAN ELECTRICAL	DRAWN BY <u>JO</u> TRACED BY <u>JO</u> CHECKED BY <u>BE</u>	E-2
CERT. NO. C-116	DATE 8/20/93	DESIGNED BY Herges, Kirchgaster, Geisler & Assoc.	DATE 8/20/93	OF 5 DRAWG. NO.