


BASEMENT FLOOR PLAN - PLUMBING & HEATING
 SCALE: 1/8" = 1'-0"

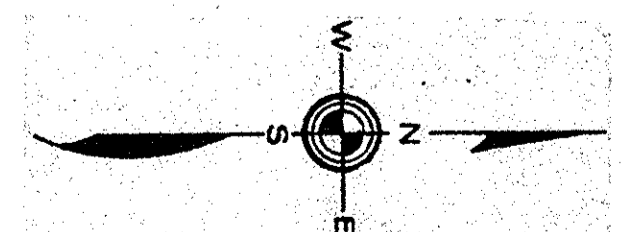

ROBY, QUINTAL & EVERSON
 CONSULTING ENGINEERS
 MITCHELL, SOUTH DAKOTA



REVISED DATE	CLASSROOM/MULTI-PURPOSE ADD.	BASEMENT FLOOR PLAN PLUMBING & HEATING	DRAWN BY <u>TL</u>
	ZION LUTHERAN CHURCH		TRACED BY <u>RE/RAG</u>
	ABERDEEN, SOUTH DAKOTA		CHECKED BY <u>TL</u>
CERT. NO. C-116	Herges, Kirchgasser, Geisler & Assoc.	Aberdeen, S.D.	DATE 8/20/93

M-2
 OF 8
 DWG. NO.